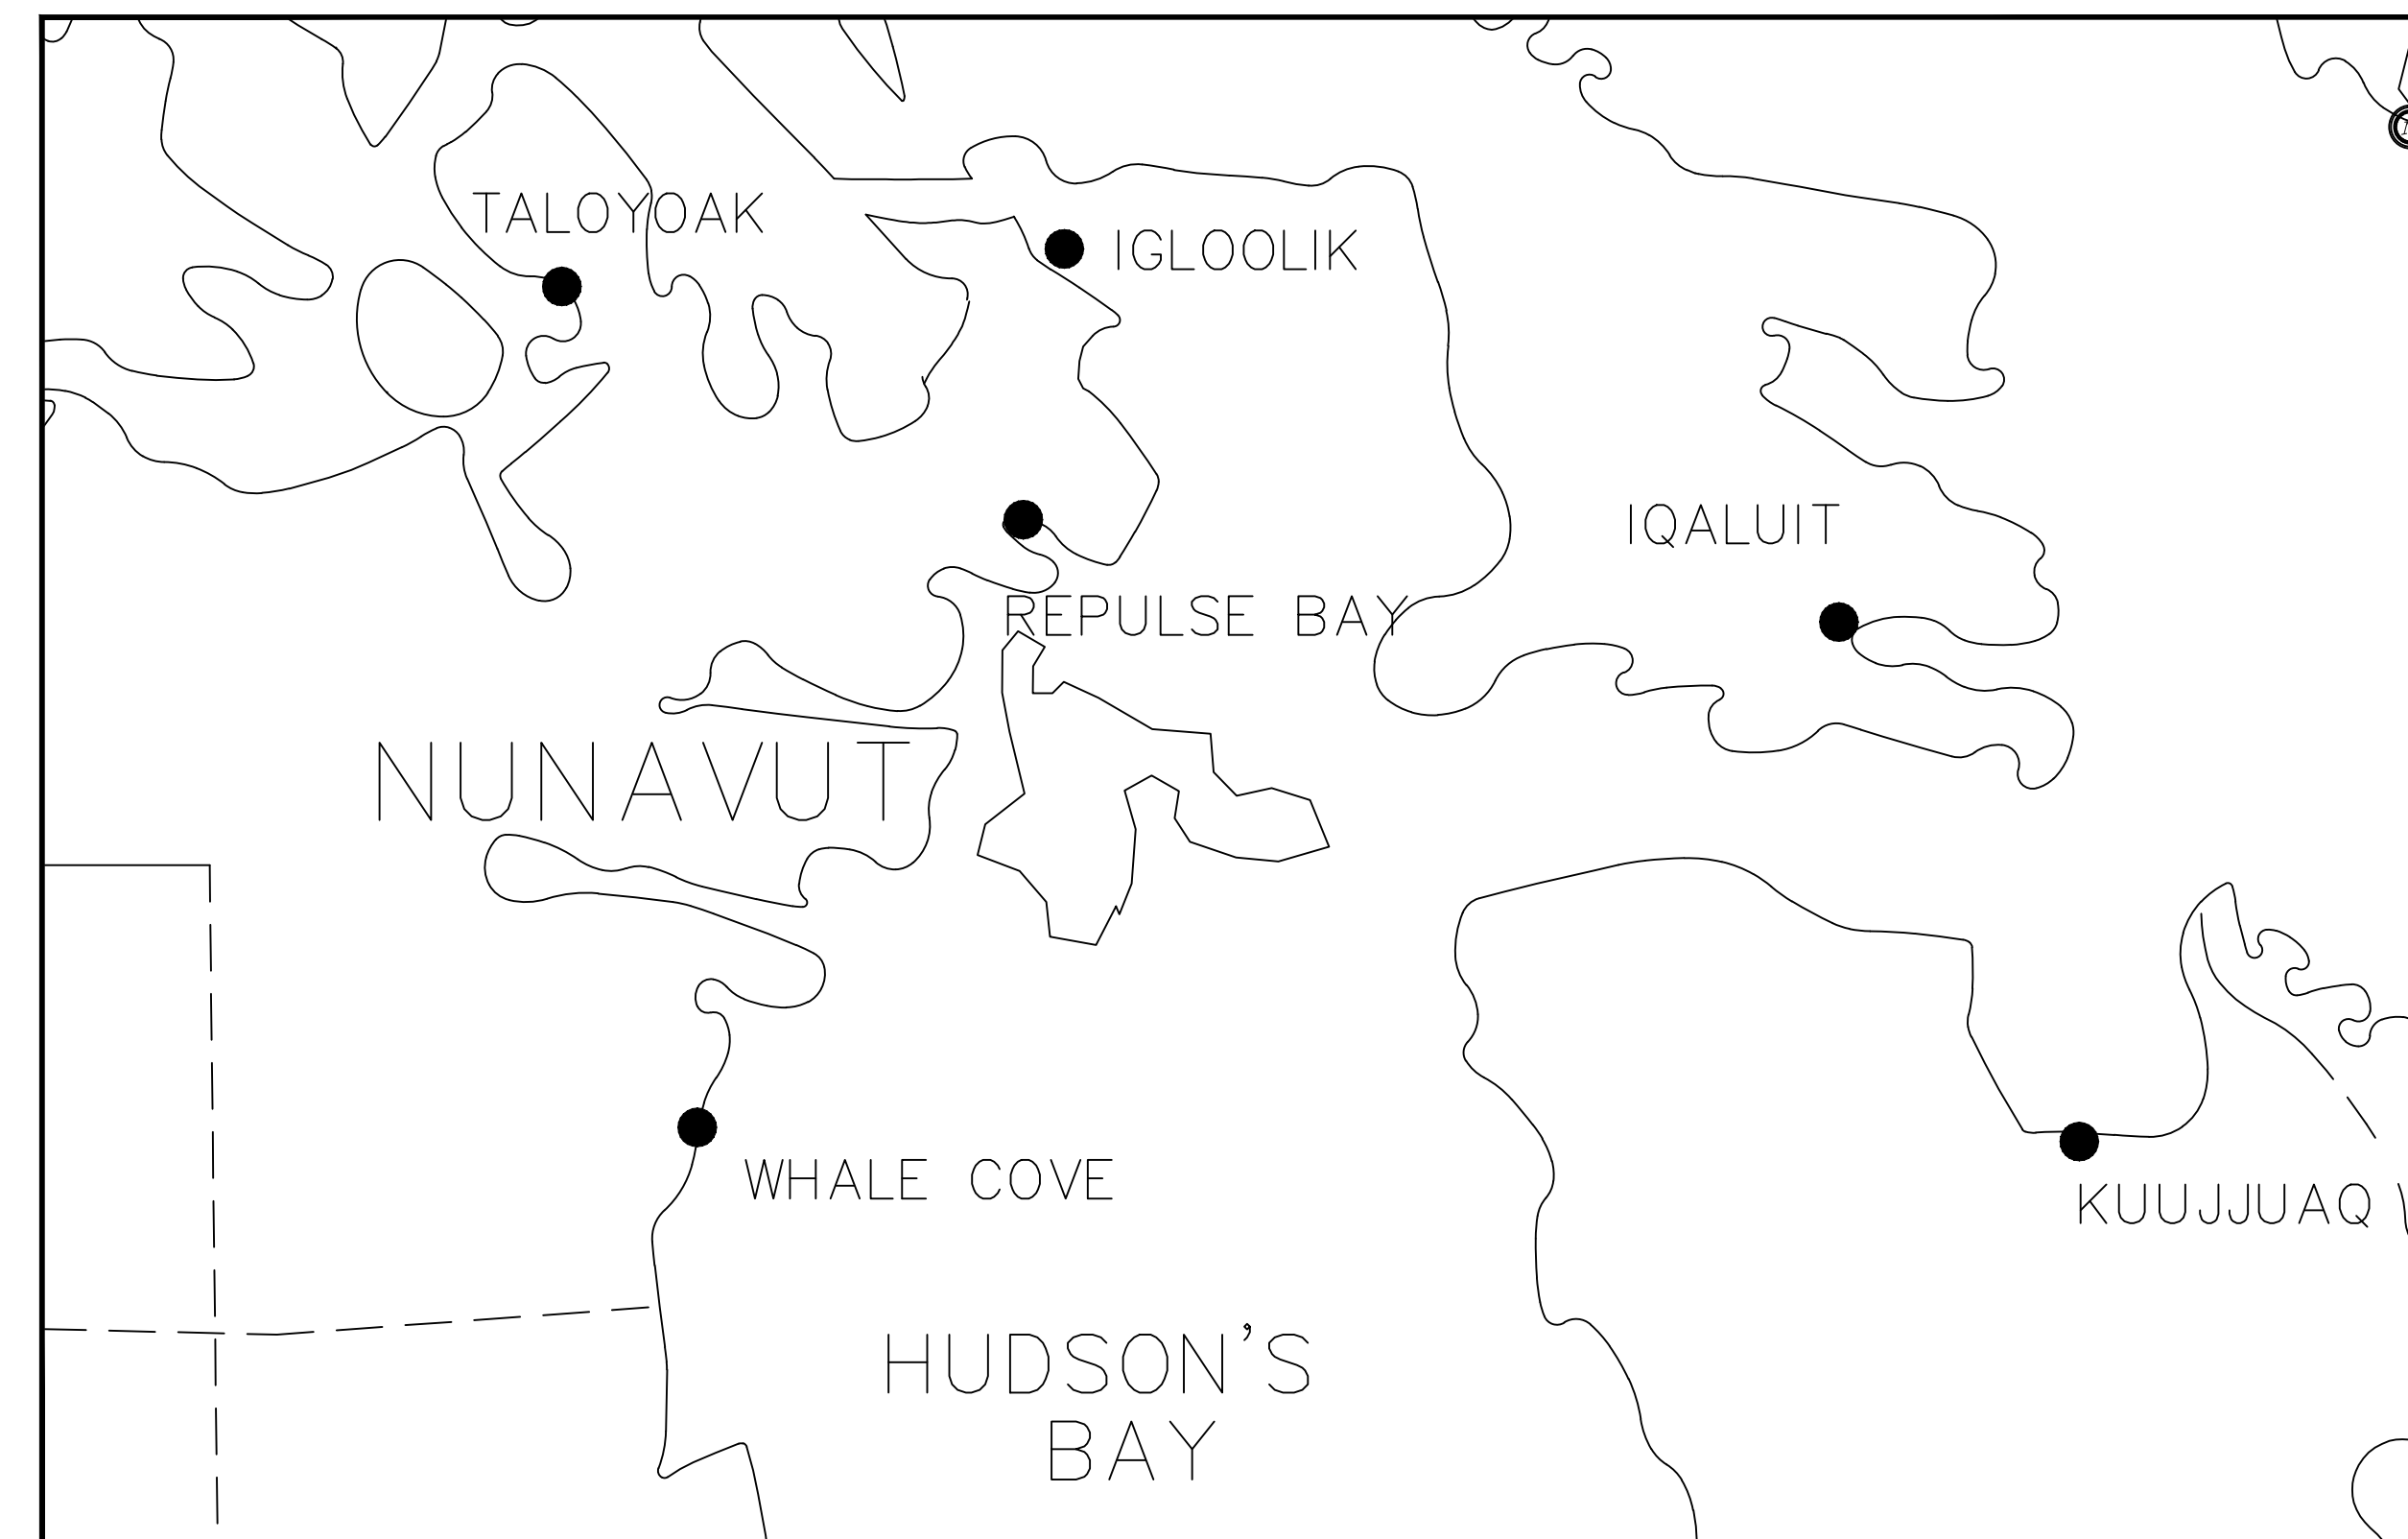


COMMUNITY OF TALOYOAK

[illegible]

EXP Services Inc.

t: +1.506.857.8889 | f: +1.506.857.8315
555 Mapleton Road, Suite 100
Moncton, NB E1G 2K5
Canada

www.exp.com

• BUILDINGS • EARTH & ENVIRONMENT • ENERGY •
• INDUSTRIAL • INFRASTRUCTURE • SUSTAINABILITY •



GOVERNMENT OF NUNAVUT

TALOYOAK SEALIFT IMPROVEMENT

PROJECT: MON-24011755-A0

90% DESIGN

DATE: DECEMBER 19, 2024

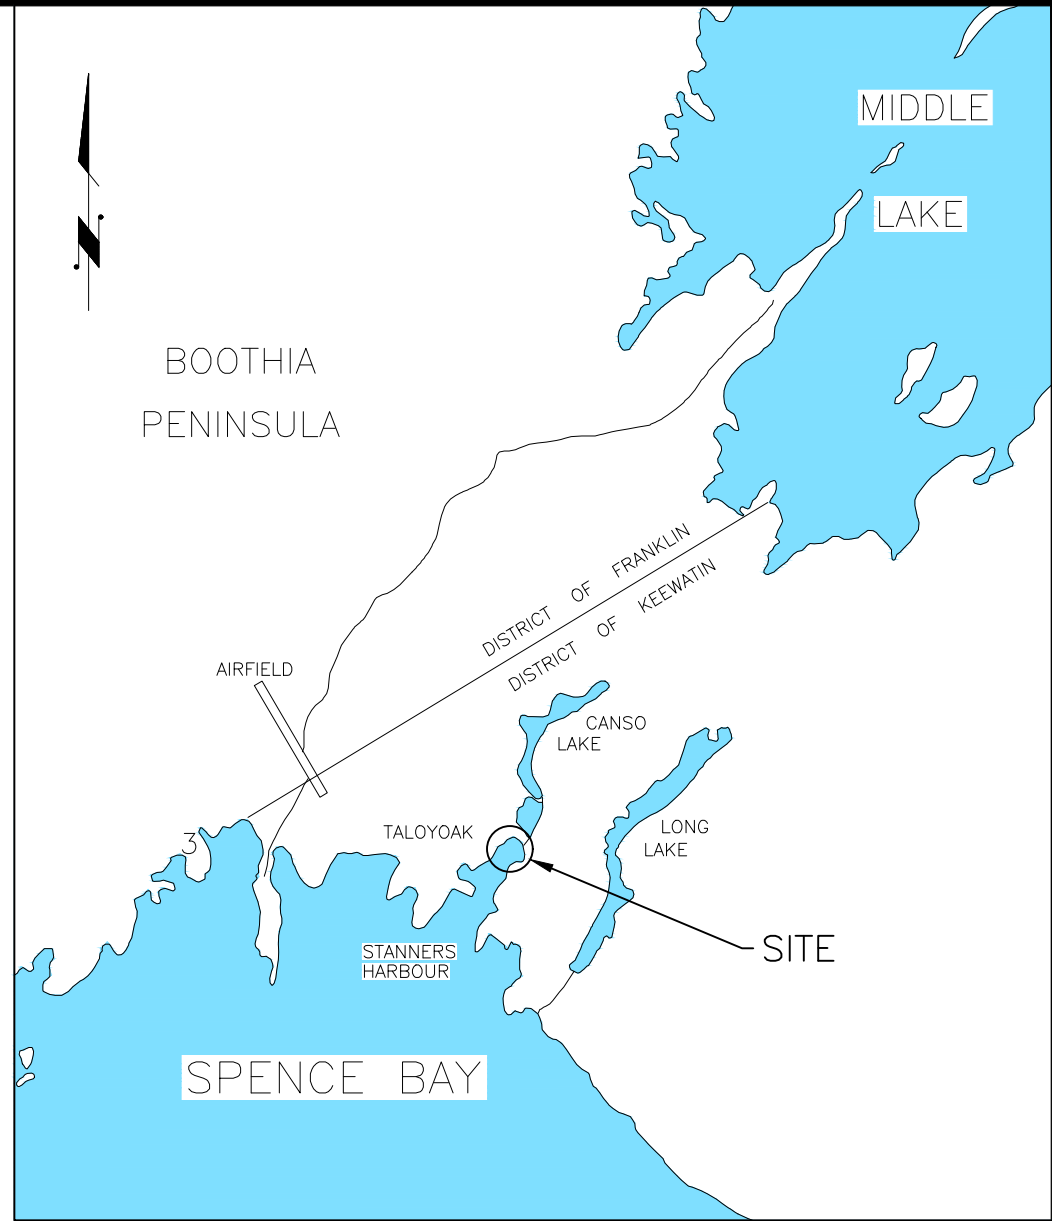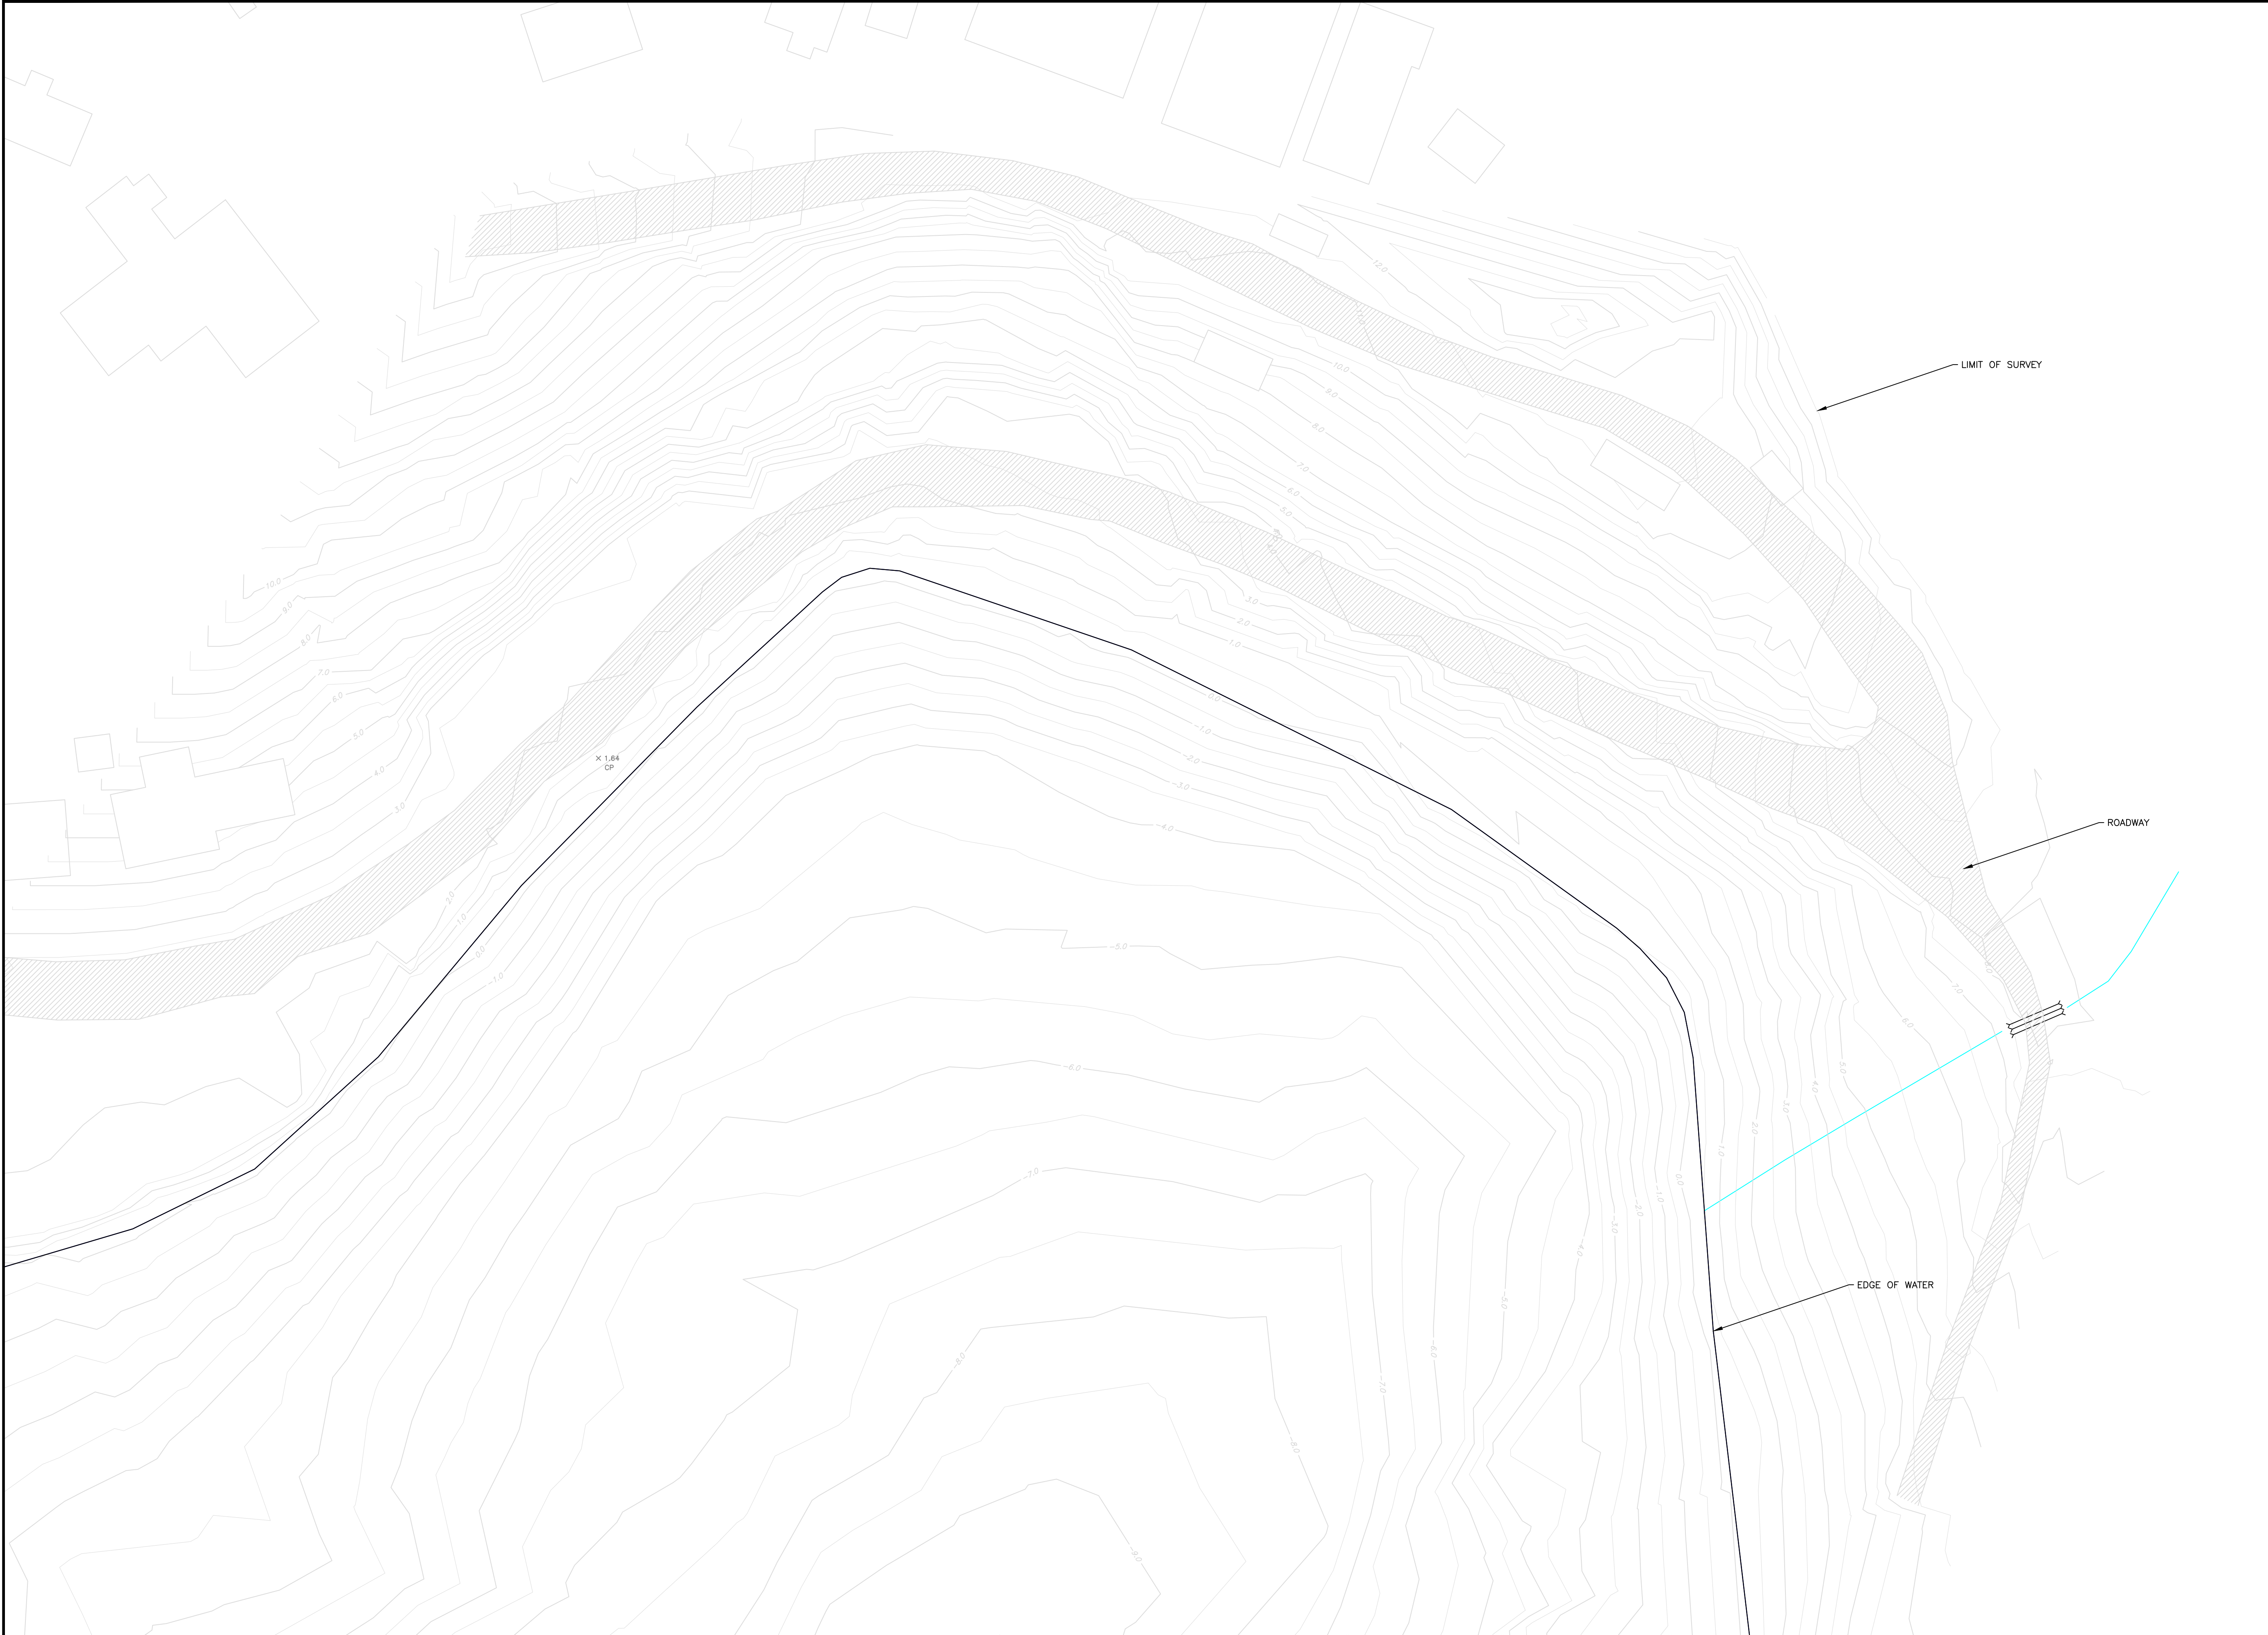

KEYPLAN
N.T.S

CONTROL MONUMENTS UTM ZONE 15 NAD 83 (CSRS), EPOCH 2010.0		
STATION	NORTHING	EASTING
CCM300	7714774.62	479608.48
CCM315	7715693.89	477230.89
CCM333	7714666.83	477909.18

LEGEND

- ROAD
- EDGE OF WATER
- CULVERT
- WATER COURSE
- MAJOR CONTOUR
- MINOR CONTOUR
- BUILDING
- TOPOGRAPHIC SURVEY POINT

NOTES

1. TOPOGRAPHIC SURVEY COMPLETED BY PILITAK ENTERPRISES AND ECCE TERRA IN OCTOBER 2024.

2. BATHYMETRIC SURVEY COMPLETED BY ECCE TERRA IN OCTOBER 2024.

PRELIMINARY

NOT FOR CONSTRUCTION

2	90% REVIEW SUBMISSION	24/12/19			
1	50% REVIEW SUBMISSION	24/11/01			
REV	REVISION DESCRIPTION	DATE	BY	APPD	

SCALE

0 4m 8m 16m

HORIZONTAL 1:400

NORTH

DESIGNED BY

REVIEWED BY

CLIENT

GOVERNMENT OF NUNAVUT

exp.

EXP Services Inc.
1-1-506-857-8888 | 1-1-506-857-8315
502 Main Street, Suite 100
Moncton, NB E1S 2G2
Canada
www.exp.com

• BUILDINGS • EARTH & ENVIRONMENT • ENERGY •
• INDUSTRIAL • INFRASTRUCTURE • SUSTAINABILITY •

BASEPLAN	DESIGN	CHECKED	CAD	PROJECT MANAGER	APPROVED
			S.BRUN	A.THOMPSON	---

PROJECT

TALOYOAK SEALIFT IMPROVEMENTS

TALOYOAK, NUNAVUT

EXISTING SITE PLAN

PROJECT No.

MON-24011755-AC

SURVEY


OCT.2024

DATE

NOV.2024

DRAWING No.

ESP

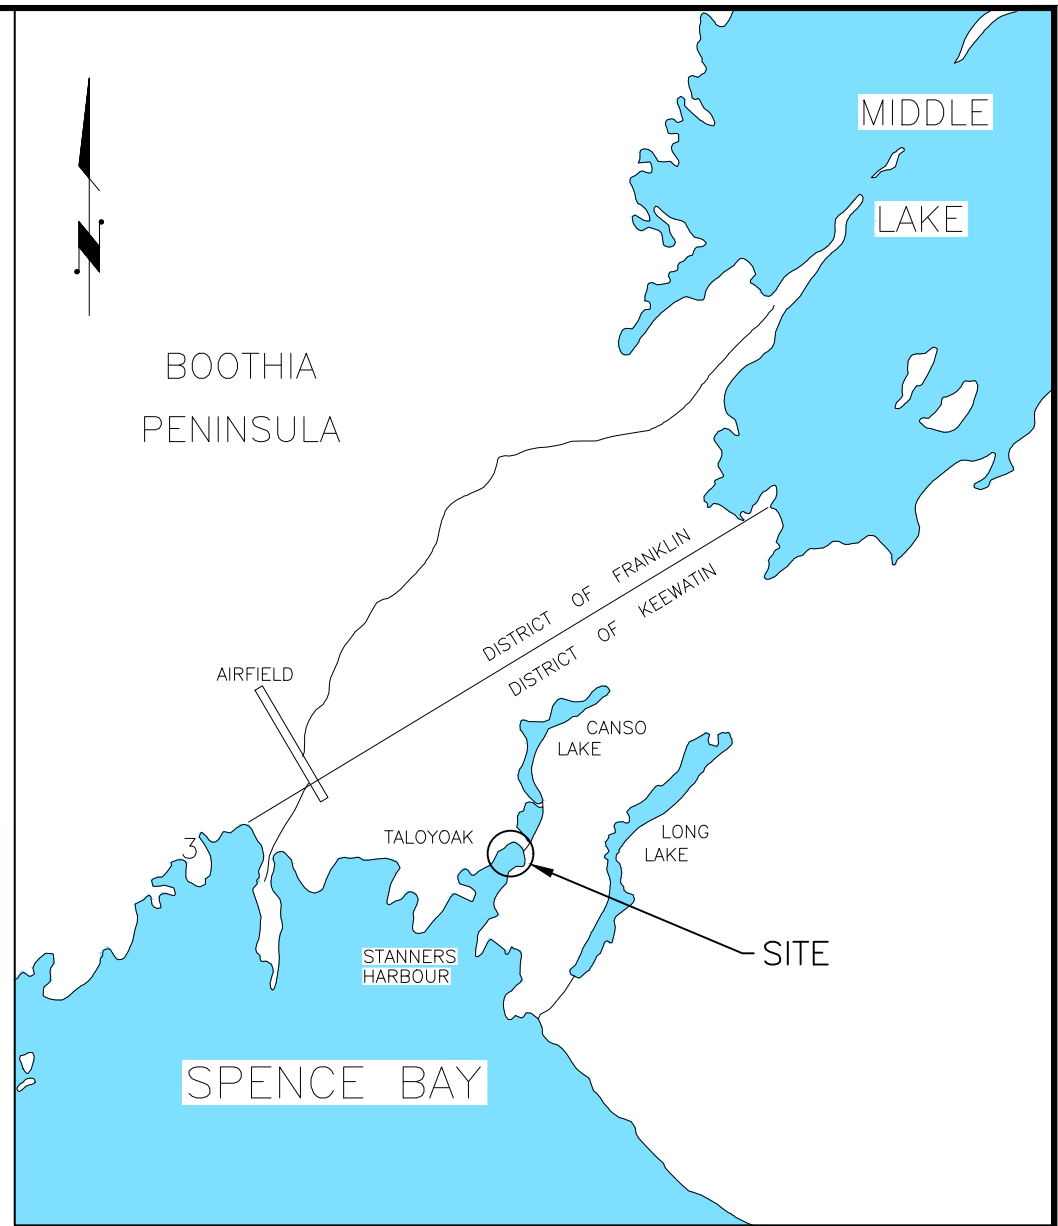

CONTROL MONUMENTS		
UTM ZONE 15 NAD 83 (CSRS), EPOCH 2010.0		
STATION	NORTHING	EASTING
CCM300	7714774.62	479608.48
CCM315	7715693.89	477230.89
CCM333	7714666.83	477909.18

LEGEND

- EXISTING ROAD
- EDGE OF WATER
- EXISTING CULVERT
- WATER COURSE
- MAJOR CONTOUR
- MINOR CONTOUR
- EXISTING BUILDING
- NEW LAYDOWN AREA
- NEW GRADING
- NEW LIGHT POLE
- NEW REFLECTOR POST
- SLOPE
- PROPOSED GRADES
- NEW BOULDERS

NOTES

1. TOPOGRAPHIC SURVEY COMPLETED BY PILITAK ENTERPRISES AND ECCE TERRA IN OCTOBER 2024.

2. BATHYMETRIC SURVEY COMPLETED BY ECCE TERRA IN OCTOBER 2024.

PRELIMINARY

NOT FOR CONSTRUCTION

2	90% REVIEW SUBMISSION	24/12/19		
1	50% REVIEW SUBMISSION	24/11/01		
REV	REVISION DESCRIPTION	DATE	BY	APPD

SCALE

0 4m 8m 16m

HORIZONTAL 1:400

NORTH

DESIGNED BY

REVIEWED BY

CLIENT

GOVERNMENT OF NUNAVUT

exp.

EXP Services Inc.
1-1-800-857-8880 | 1-506-857-8315
502 Main Street, Suite 100
Moncton, NB E1C 2K2
Canada
www.exp.com

• BUILDINGS • EARTH & ENVIRONMENT • ENERGY •
• INDUSTRIAL • INFRASTRUCTURE • SUSTAINABILITY •

BASEPLAN	DESIGN	CHECKED	CAD	PROJECT MANAGER	APPROVED
			S.BRUN	A.THOMPSON	

PROJECT

TALOYOAK SEALIFT IMPROVEMENTS

TALOYOAK, NUNAVUT

OVERALL SITE PLAN

PROJECT No.

MON-24011755-AD

SURVEY

OCT.2024


DATE

DEC.2024


DRAWING No.

OSP

File name: E:\MON\NUN-24011755-AQ\00 Execution\05 Drawings\008 design.dwg\008 OSP and CROSS SECTIONS.dwg
User: A. Thompson
Printed: Dec 19, 2024 2:11 PM
Plotted by: BrunS
References:

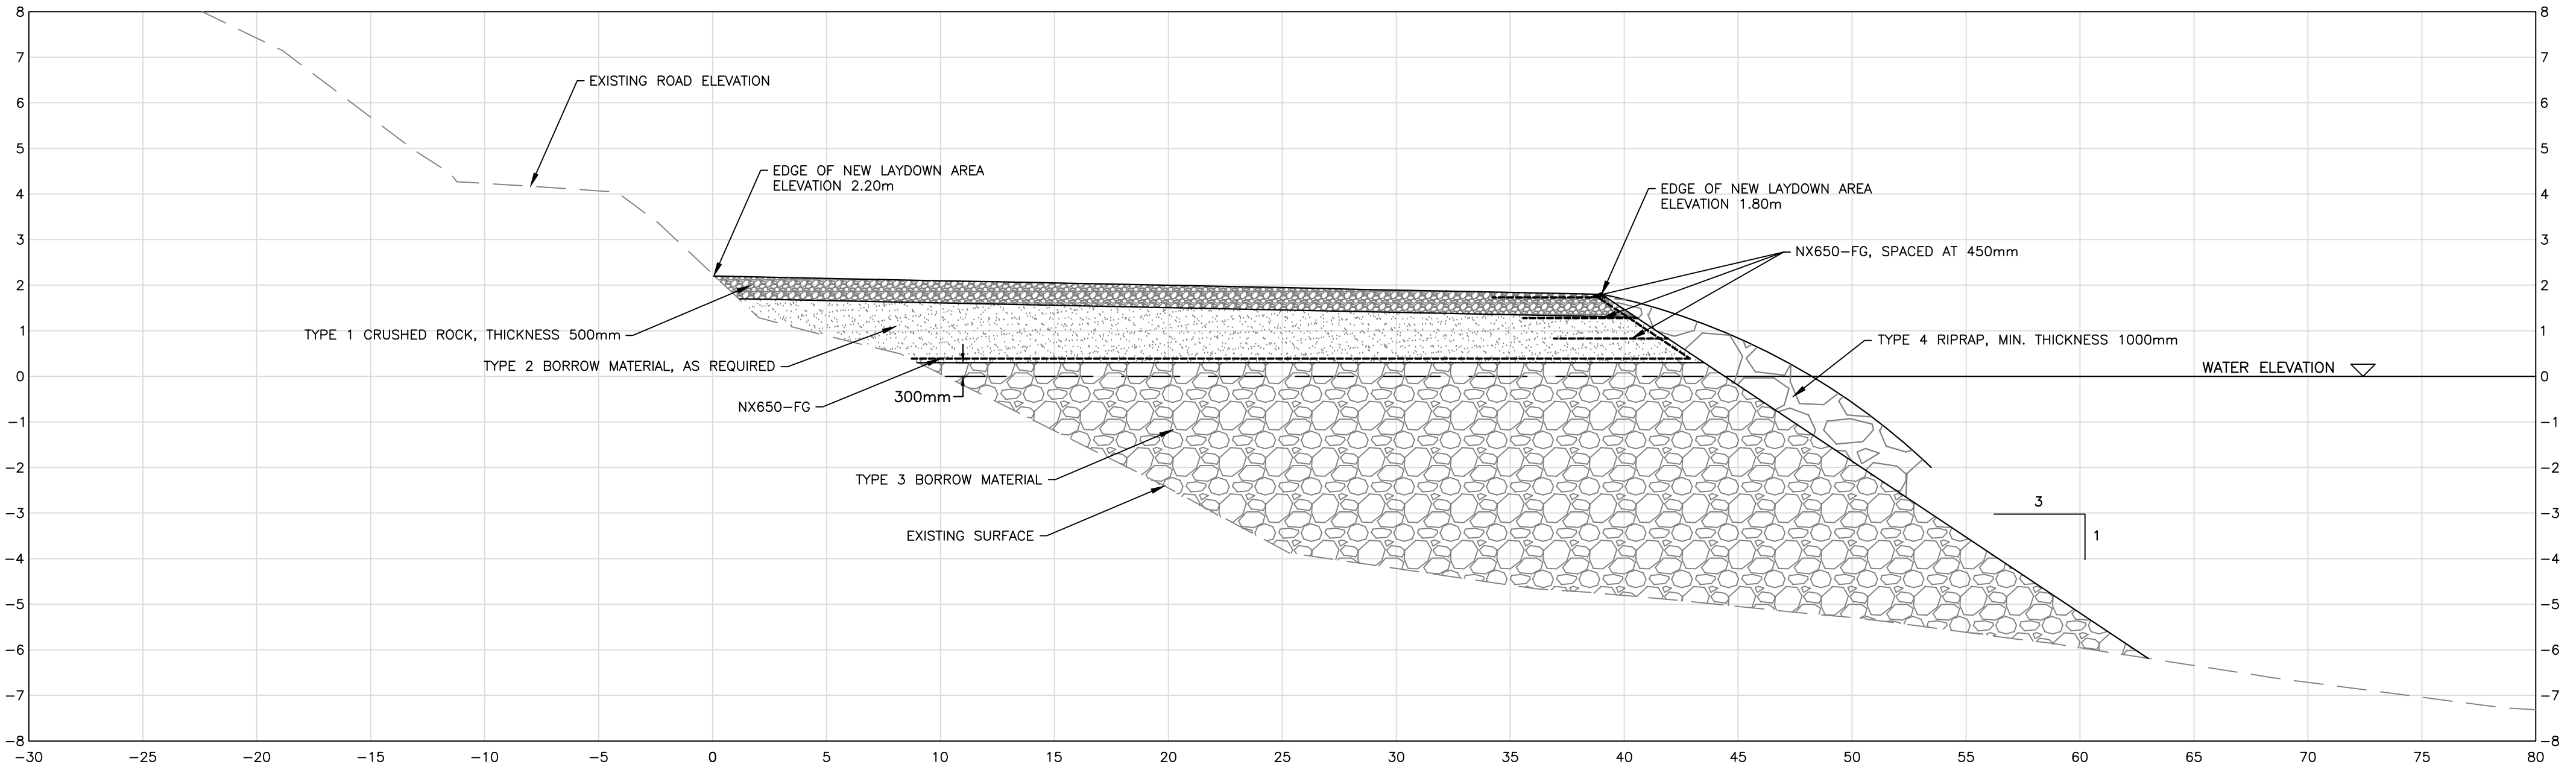

CROSS SECTION 'A'
SCALE = 1:1000 HORIZONTAL, 1:500 VERTICAL

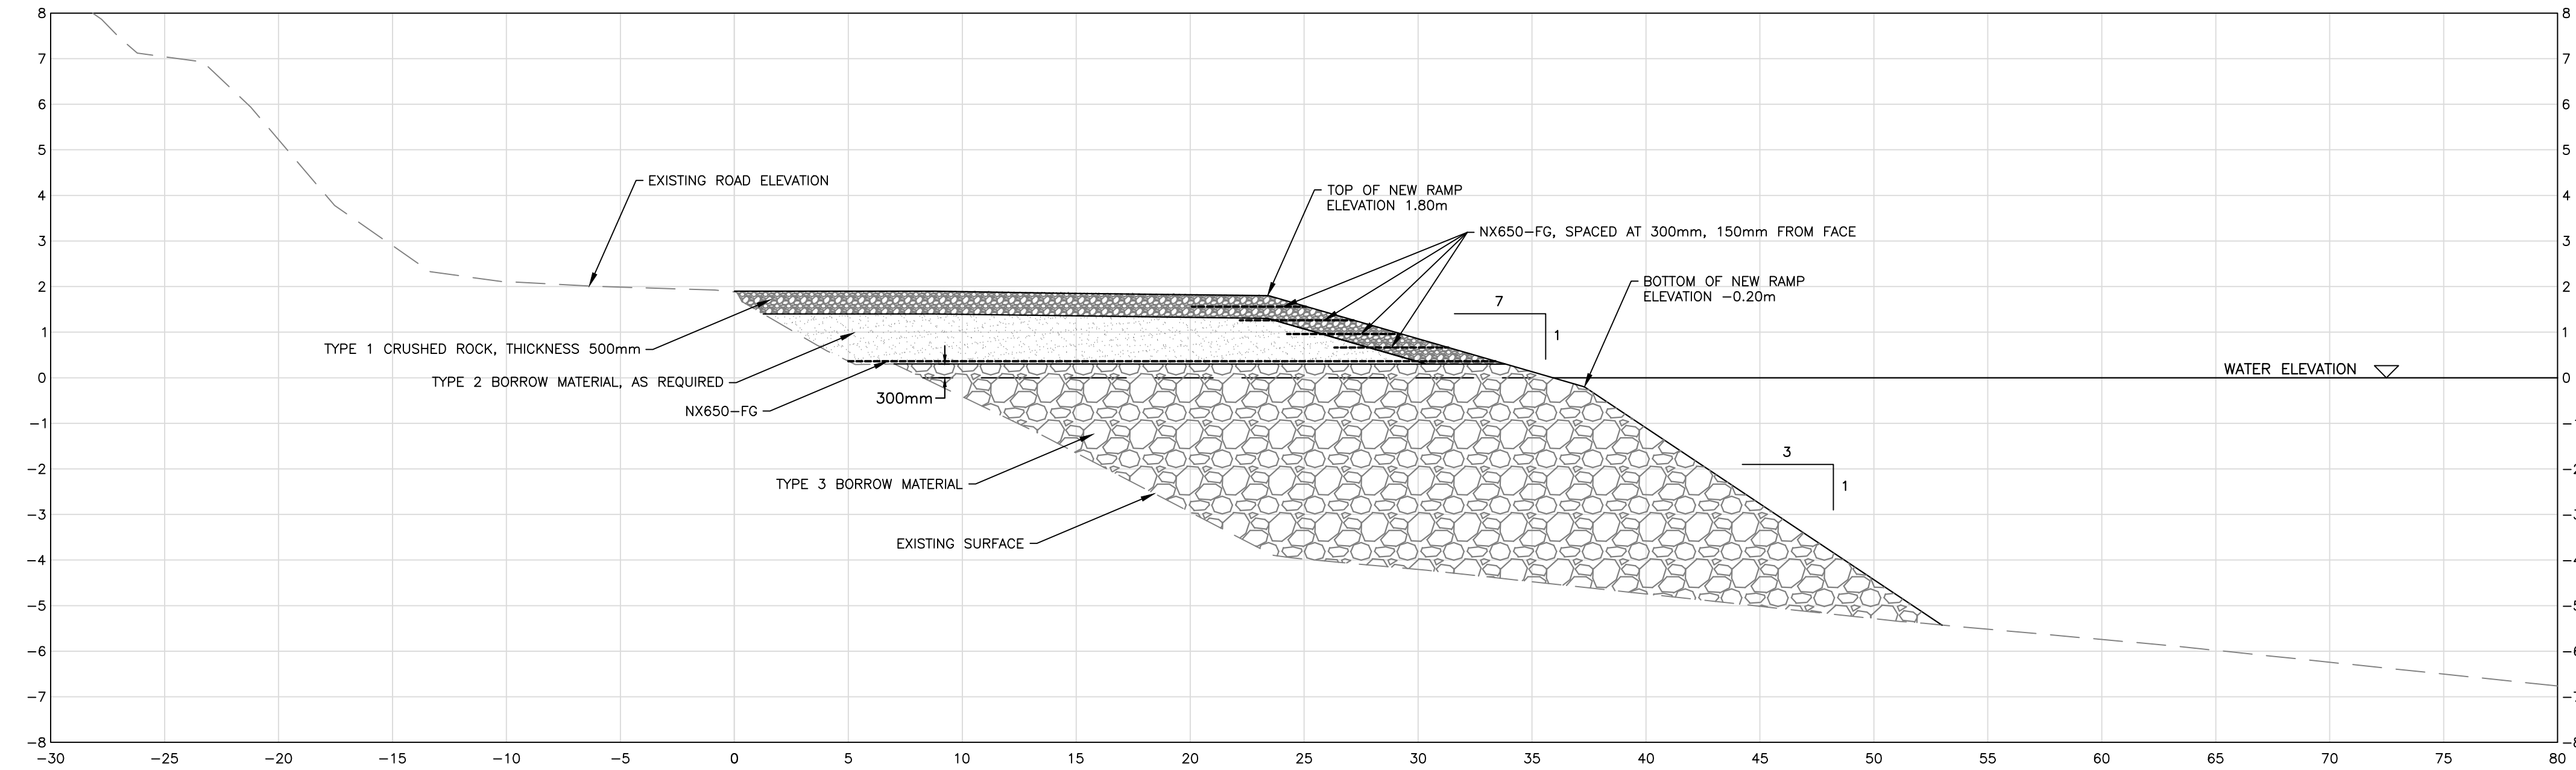

CROSS SECTION 'B'
SCALE = 1:1000 HORIZONTAL, 1:500 VERTICAL

NOTES
1. TOPOGRAPHIC SURVEY COMPLETED BY PILITAK ENTERPRISES AND ECCE TERRA IN OCTOBER 2024.
2. BATHYMETRIC SURVEY COMPLETED BY ECCE TERRA IN OCTOBER 2024.

PRELIMINARY
NOT FOR CONSTRUCTION

REV	REVISION DESCRIPTION	DATE	BY	APPD
2	90% REVIEW SUBMISSION	24/12/19		
1	50% REVIEW SUBMISSION	24/11/01		

SCALE	AS SHOWN
NORTH	


DESIGNED BY	
REVIEWED BY	

CLIENT	GOVERNMENT OF NUNAVUT
--------	-----------------------

BASEPLAN	DESIGN
CHECKED	
CAD	S.BRUN
PROJECT MANAGER	A.THOMPSON
APPROVED	

PROJECT	TALOYOAK SEALIFT IMPROVEMENTS
TITLE	CROSS SECTIONS

PROJECT No.	MON-24011755-AQ
SURVEY	OCT.2024
DATE	DEC.2024
DRAWING No.	DET-1

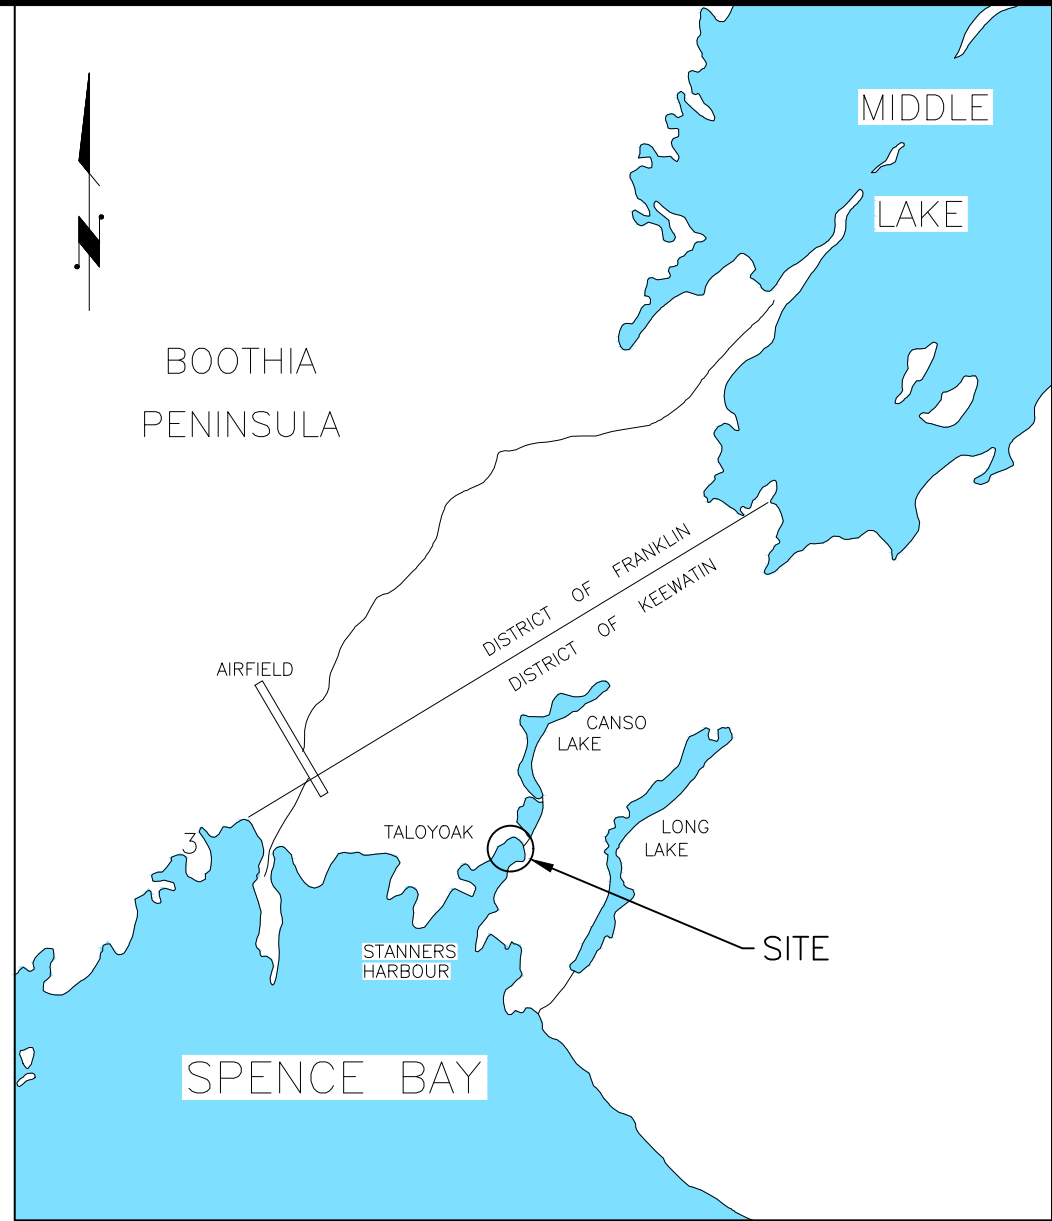

CONTROL MONUMENTS UTM ZONE 15 NAD 83 (CSRS), EPOCH 2010.0		
STATION	NORTHING	EASTING
CCM300	7714774.62	479608.48
CCM315	7715693.89	477230.89
CCM333	7714666.83	477909.18

LEGEND

- ROAD
- EDGE OF WATER
- CULVERT
- WATER COURSE
- MAJOR CONTOUR
- MINOR CONTOUR
- BUILDING
- GRADING
- NEW LIGHT POLE
- EXISTING UTILITY POLE
- NEW OVERHEAD LINES
- PROPOSED GRADES


LIGHT POLES

Point Table			
Point #	Raw Description	Northing	Easting
289	LP	7714378.7234	479671.7412
290	LP	7714406.2980	479720.0855
291	LP	7714394.1908	479746.6749
292	LP	7714379.6016	479773.9112
293	LP	7714363.3319	479799.1085
294	LP	7714335.3828	479809.4656

NOTES
1. TOPOGRAPHIC SURVEY COMPLETED BY PILITAK ENTERPRISES AND ECCE TERRA IN OCTOBER 2024.
2. BATHYMETRIC SURVEY COMPLETED BY ECCE TERRA IN OCTOBER 2024.

PRELIMINARY
NOT FOR CONSTRUCTION

REV	REVISION DESCRIPTION	DATE	BY	APPD
2	90% REVIEW SUBMISSION	24/12/19		
1	50% REVIEW SUBMISSION	24/11/01		

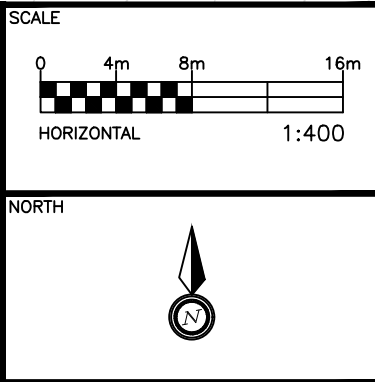

DESIGNED BY
REVIEWED BY

CLIENT
GOVERNMENT OF NUNAVUT

exp. EXP Services Inc.
1-1-206-857-8880 | 1-1-506-857-8315
502 Main Street, Suite 100
Moncton, NB E1C 2K5
Canada
www.exp.com
• BUILDINGS • EARTH & ENVIRONMENT • ENERGY •
• INDUSTRIAL • INFRASTRUCTURE • SUSTAINABILITY •

BASEPLAN
DESIGN
CHECKED
CAD
PROJECT MANAGER
APPROVED

PROJECT
TALOYOAK SEALIFT IMPROVEMENTS
TALOYOAK, NUNAVUT
75% ELECTRICAL SITE PLAN

PROJECT No.
MON-24011755-AD
SURVEY
OCT.2024
DATE
DEC.2024
DRAWING No.
ELSP