

NOTES:

- PROPERTY BOUNDARIES SHOWN ARE APPROXIMATE, SEE NORTH WARNING SYSTEM REAL PROPERTY STATEMENT OF WORK DRAWING PACKAGE FOR THIS SITE'S PRECISE PROPERTY BOUNDARIES.

--- ABOVEGROUND P.O.L. LINE
--- ELECTRICAL CABLE

DRAWING DERIVED FROM PROJECT NO. 499559

NO.	DATE	REVISION	APPR.
1	10 OCT 18	REV AS PER ENVIRO. MARK-UPS	WW

SCALE | ÉCHELLE
N.T.S.

LOCATION | EMPLACEMENT
**FOX-M
HALL BEACH
NUNAVUT**
PROJECT | PROJET

TRADE | MÉTIER
SITING

DATE
2017/06/01

SUBJECT | SUJET

SITE PLAN


PRODUCTION	DESIGNED ÉTUDIÉ	REVIEWED REVU	DES O AGENT CONC
A.B.			
DRAWN DESSINÉ			PROJ MGR GEST PROJ
T.R.			P.W.
CHECKED VÉRIFIÉ			DES MGR GEST CONC
M.L.			F.M.
COORDINATION			FIRE INCENDIE
			D.S.

WBS NO. | NO. OTP

PF NO. | NO. DP

DWG. NO. | NO. DESSIN

SK2-5910-102

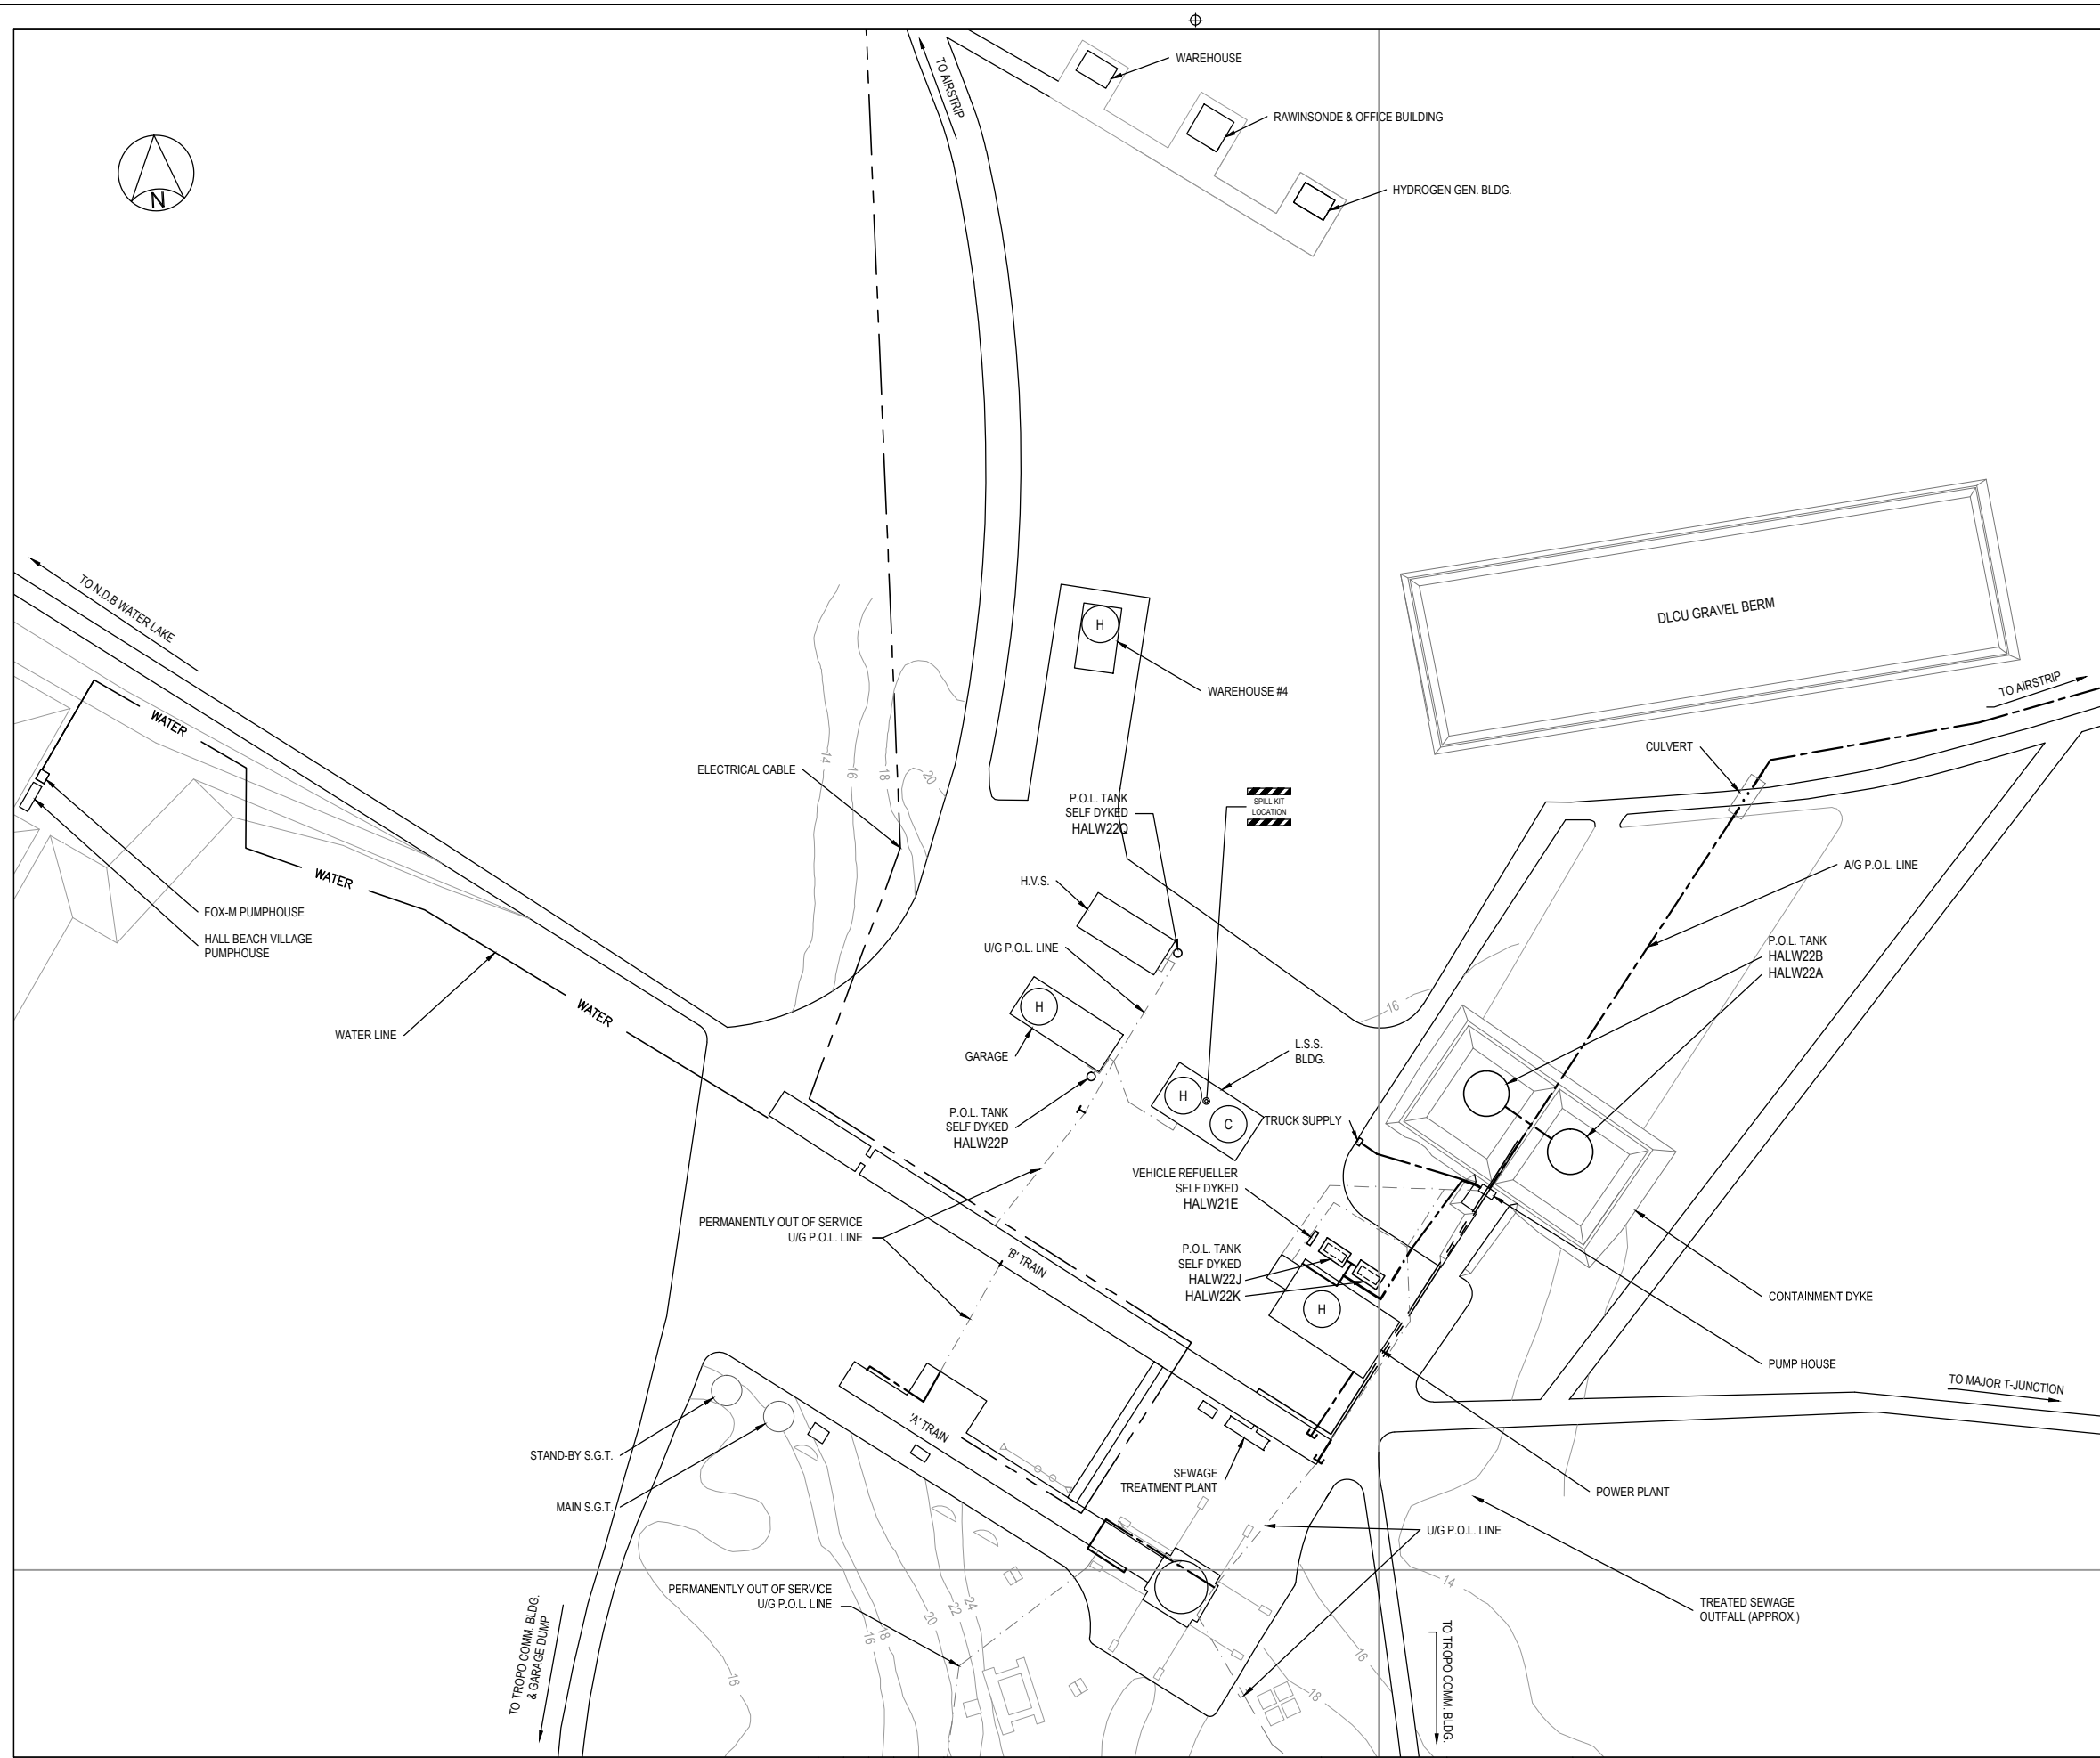

Government of Canada Gouvernement du Canada

LEVEL OF SECURITY | NIVEAU DE SÉCURITÉ
TO BE REVIEWED | À ÊTRE RÉVISÉ

NORTH WARNING SYSTEM OFFICE
Bureau du système d'alerte du Nord

Raytheon
Canada Limited

Suite 3000-400 COOPER STREET
OTTAWA, ONTARIO K2P 2H8
TEL.: (613) 787-3630
FAX.: (613) 787-3703

LOCATION



NOTES:

— — — ABOVEGROUND P.O.L. LINE

--- UNDERGROUND P.O.L. LINE

--- ELECTRICAL CABLE

PERMANENTLY OUT OF
SERVICE P.O.L. LINE



P.O.L. SPILL KIT



HAZMAT STORAGE



CHEMICAL SPILL KIT

DRAWING DERIVED FROM PROJECT NO. 499559

1	10 OCT 18	REV AS PER ENVIRO. MARK-UPS	WV
NO.	DATE	REVISION	APP

SCALE | ÉCHELLE
N.T.S.

LOCATION | EMPLACEMENT

FOX-M
HALL BEACH
NUNAVUT

PROJECT | PROJET

TRADE | MÉTIER
SITING

DATE	2017/06/01
------	------------

SUBJECT SUJET

SUMMIT AREA PLAN

PRODUCTION	REVIEWED REVU	
DESIGNED ETUDIÉ A.B.		DES O AGENT CONCO
DRAWN DESSINÉ T.R.		PROJ MGR GEST PR P.W.
CHECKED VERIFIÉ M.L.		DES MGR GEST CON F.M.
COORDINATION		FIRE INCENDIE D.S.

DWG. NO. NO. DESSIN

H-H11/2-5910-103

Canada