
 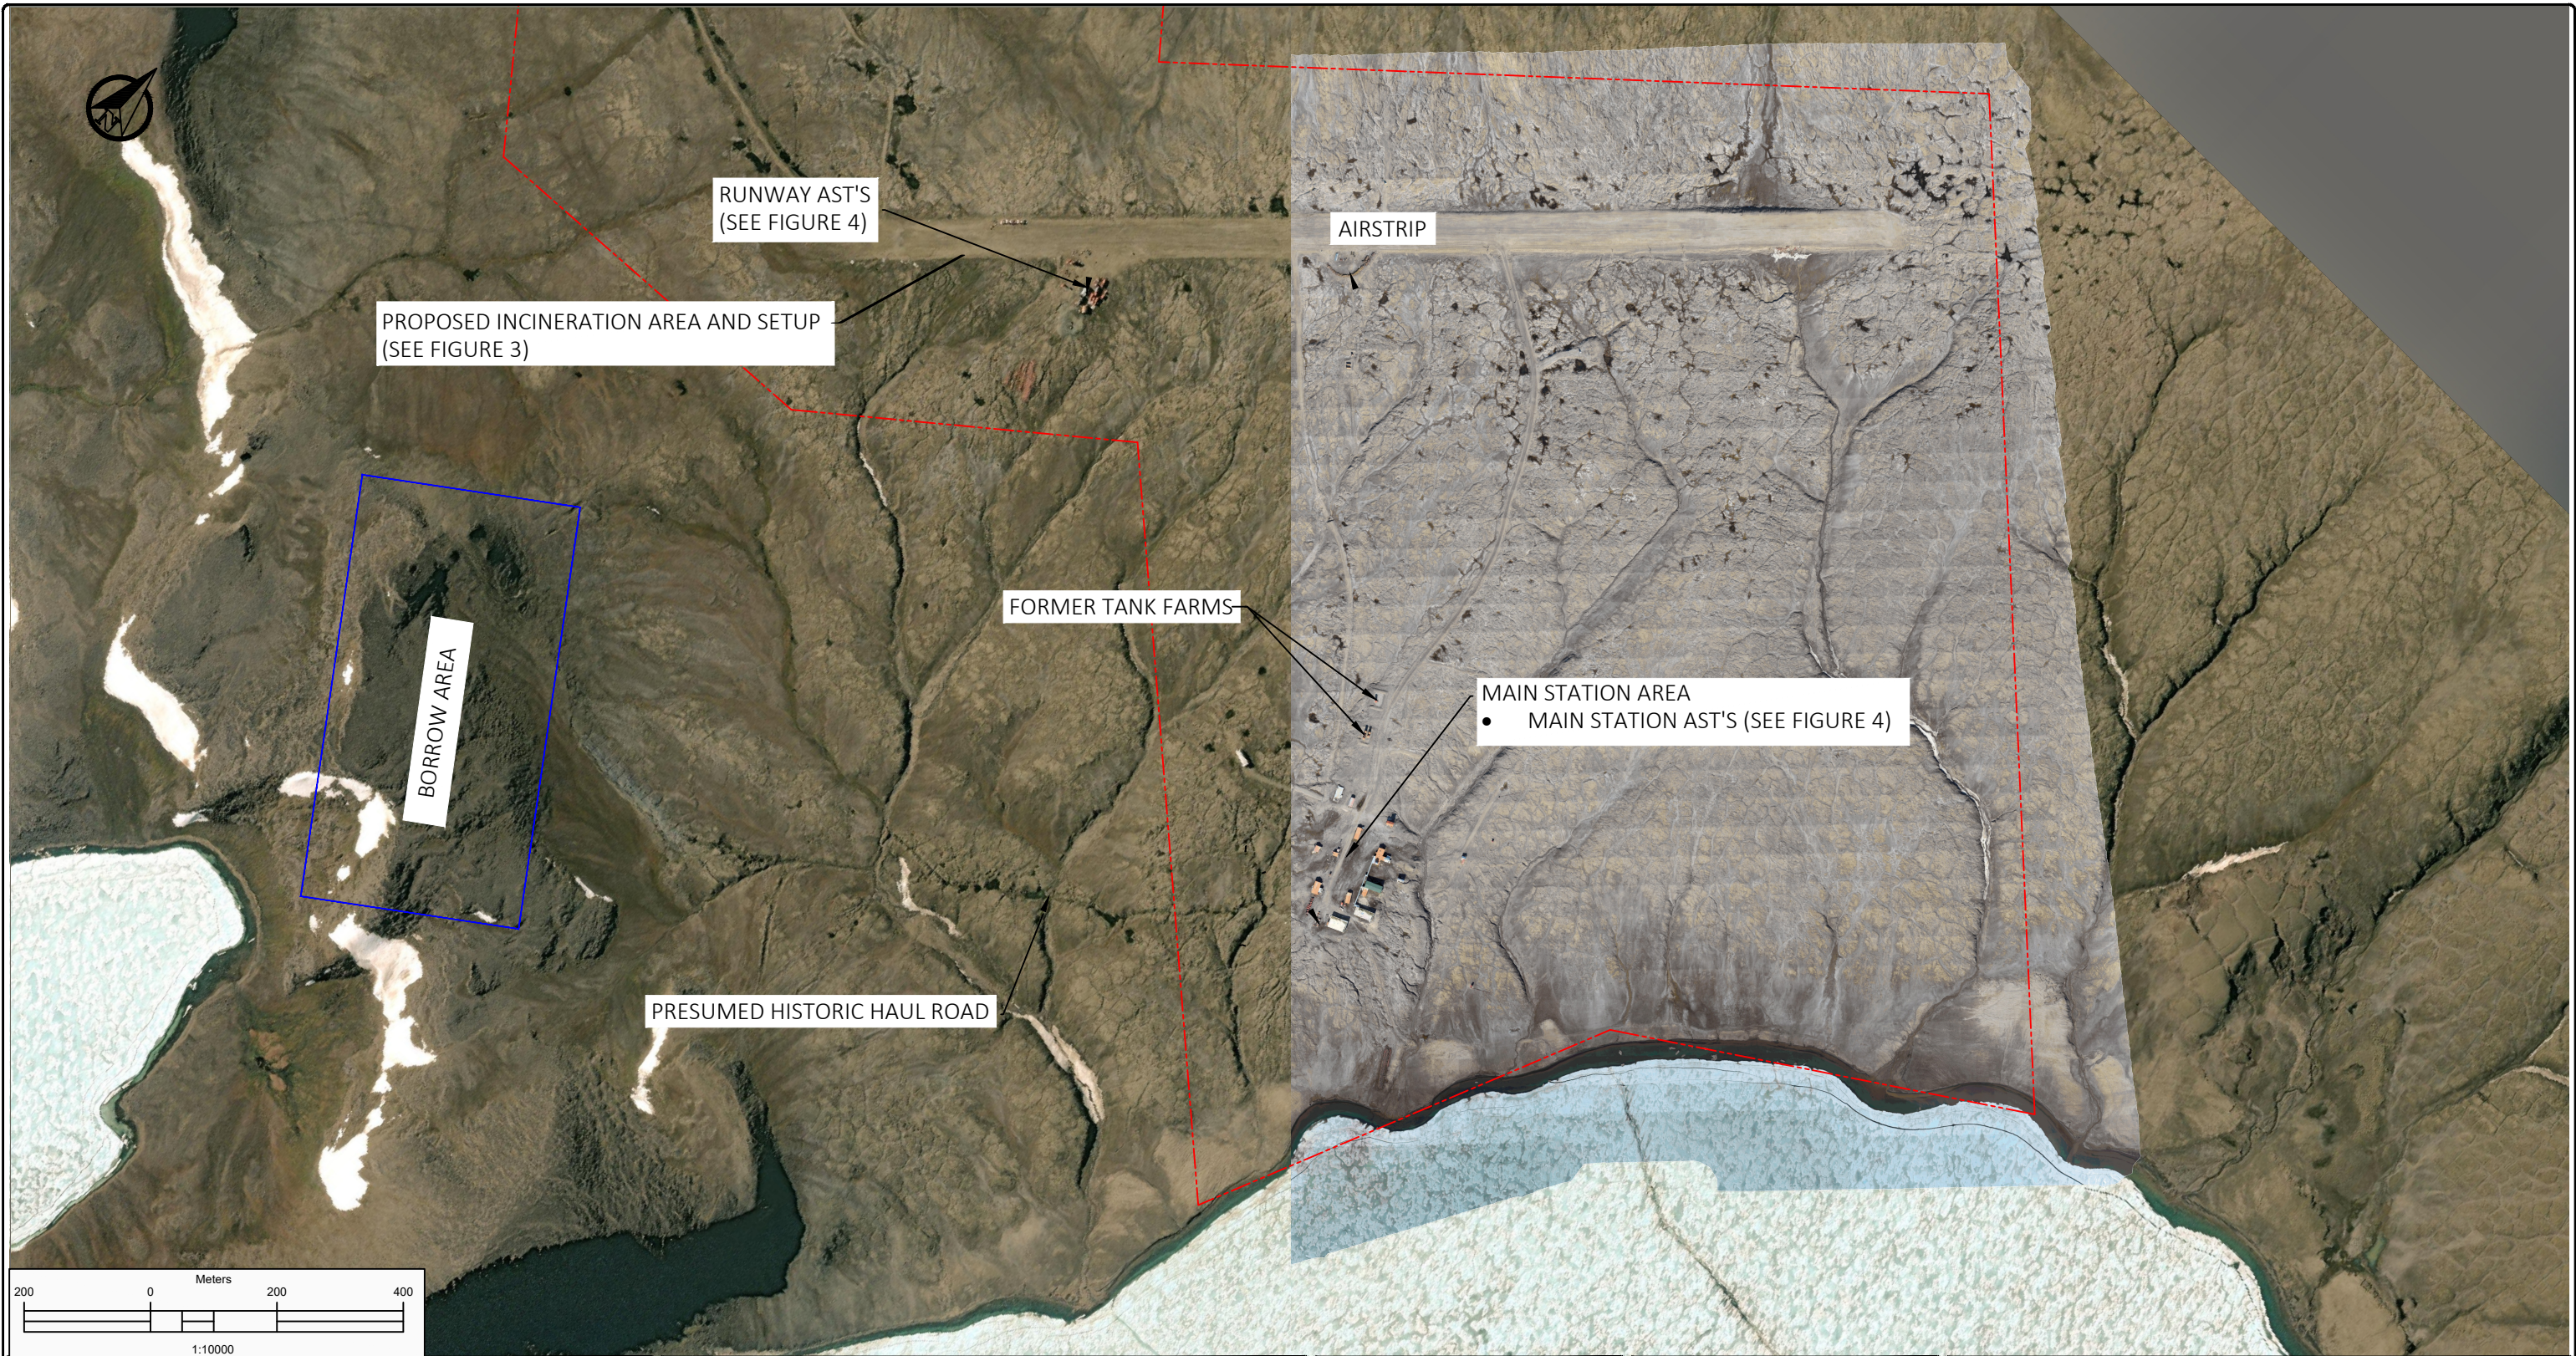




GENERAL NOTES

1. ALL MEASUREMENTS IN METRES UNLESS OTHERWISE NOTED
2. COORDINATE SYSTEM IS NAD83 (CSRS) / UTM ZONE 13N

LEGEND	
	DFRP PROPERTY LINE


**NUQSANA**Inc.

11-1 MIVVIK AVE.
RANKIN INLET, NUNAVUT
X0C 0G0
t:867.645.7533



151 HOLLAND AVE SUITE 200
OTTAWA, ONTARIO
K1Y 0Y2
t:613.729.2402

ISACHSEN HIGH ARCTIC WEATHER STATION ELLEF RINGNESS ISLAND, NUNAVUT SPILL PROTECTION AND RESPONSE PLAN - FIGURE 2 SITE PLAN/ KEY FEATURES			
OUTCOME PROJECT NUMBER: P2023-16	DRAWN BY: J.MILLS	SCALE: 1:10000	REV: 00
CLIENT PROJECT NUMBER: R.125553.001	CHECKED BY: C.SADLER	PUBLISH DATE: 2025-02-27	
DRAWING NAME: P2023-16 ISACHSEN RAP FIGURES.dwg	SHEET NUMBER: FIGURE 2		

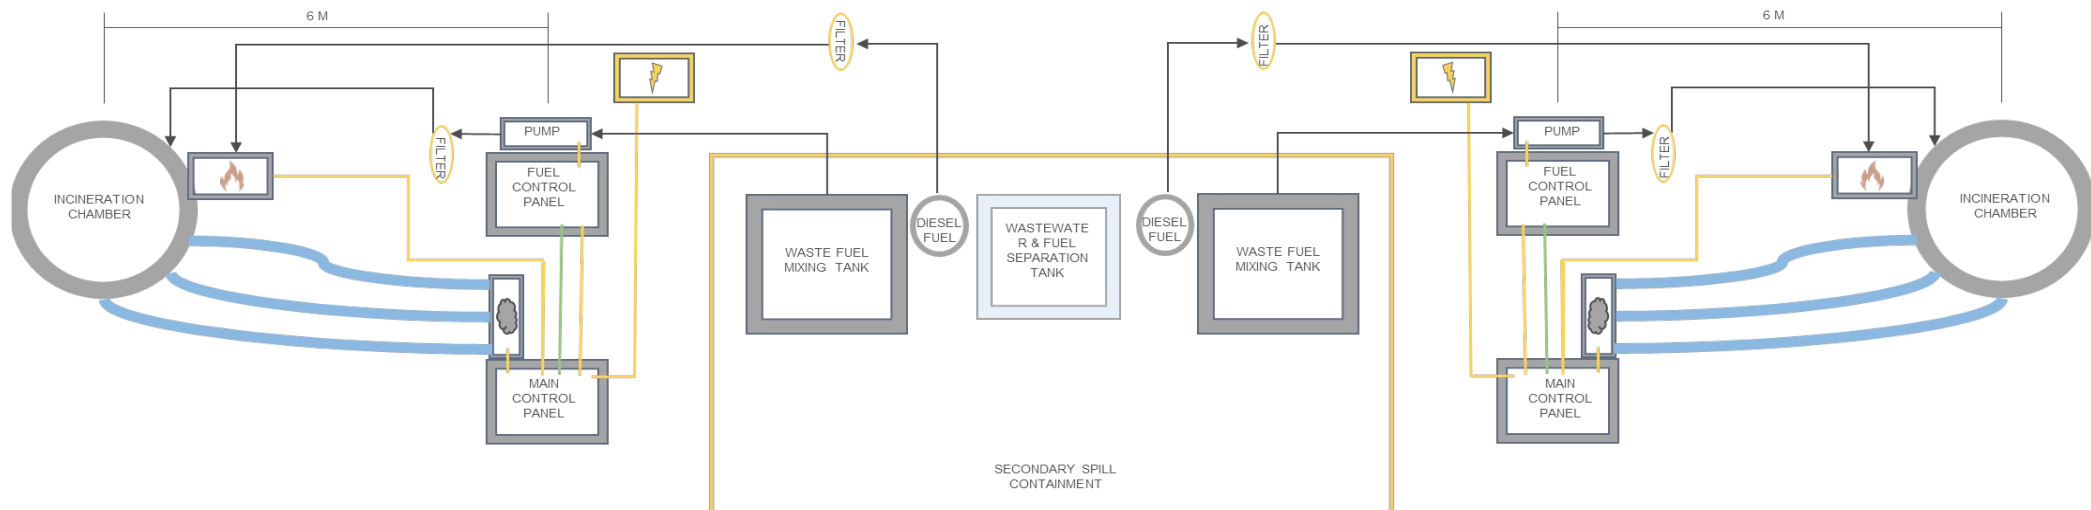

GENERAL NOTES INCINERATOR SETUP BLUEPRINT APLICABLE FOR INCINERATIONS 9570A & 9570B	LEGEND - ELECTRICAL LINE - DATA LINE - POWER SUPPLY - BLOWER - PILOT BURNER - AIR LINE	151 HOLLAND AVE SUITE 200 OTTAWA, ONTARIO K1Y 0Y2 t:613.729.2402		ISACHSEN HIGH ARCTIC WEATHER STATION ELLEF RINGNESS ISLAND, NUNAVUT SPILL PROTECTION AND RESPONSE PLAN - FIGURE 3 INCINERATION SETUP		
				OUTCOME PROJECT NUMBER: NP2023-16	DRAWN BY: E.GRIMMINCK	SCALE: 1:110
				CLIENT PROJECT NUMBER: NP2023-16	CHECKED BY: K.VEITCH	PUBLISH DATE: 2024-04-08
				DRAWING NAME: NP2023-16 ISACHSEN INC SETUP.dwg	SHEET NUMBER: 	SHEET NUMBER: 01 OF 01

THIS DRAWING IS THE PROPERTY OF OUTCOME CONSULTANTS INC. AND IS NOT TO BE LOANED OR REPRODUCED IN ANY WAY WITHOUT THE PERMISSION OF OUTCOME CONSULTANTS INC.